



PROPOSED PROJECT
MONTVILLE ANIMAL HOSPITAL LLC
480 NORWICH-NEW LONDON TNPk
MONTVILLE, CT

SHEET LIST	
SHEET	DESCRIPTION
A1.0	COVER SHEET
A1.1	MAIN FLOOR ALTERATION PLANS
A1.2	UPPER FLOOR ALTERATION PLANS
A2.1	PROPOSED MAIN FLOOR PLANS
A2.2	PROPOSED UPPER FLOOR PLANS
P1.1	PLUMBING DETAILS

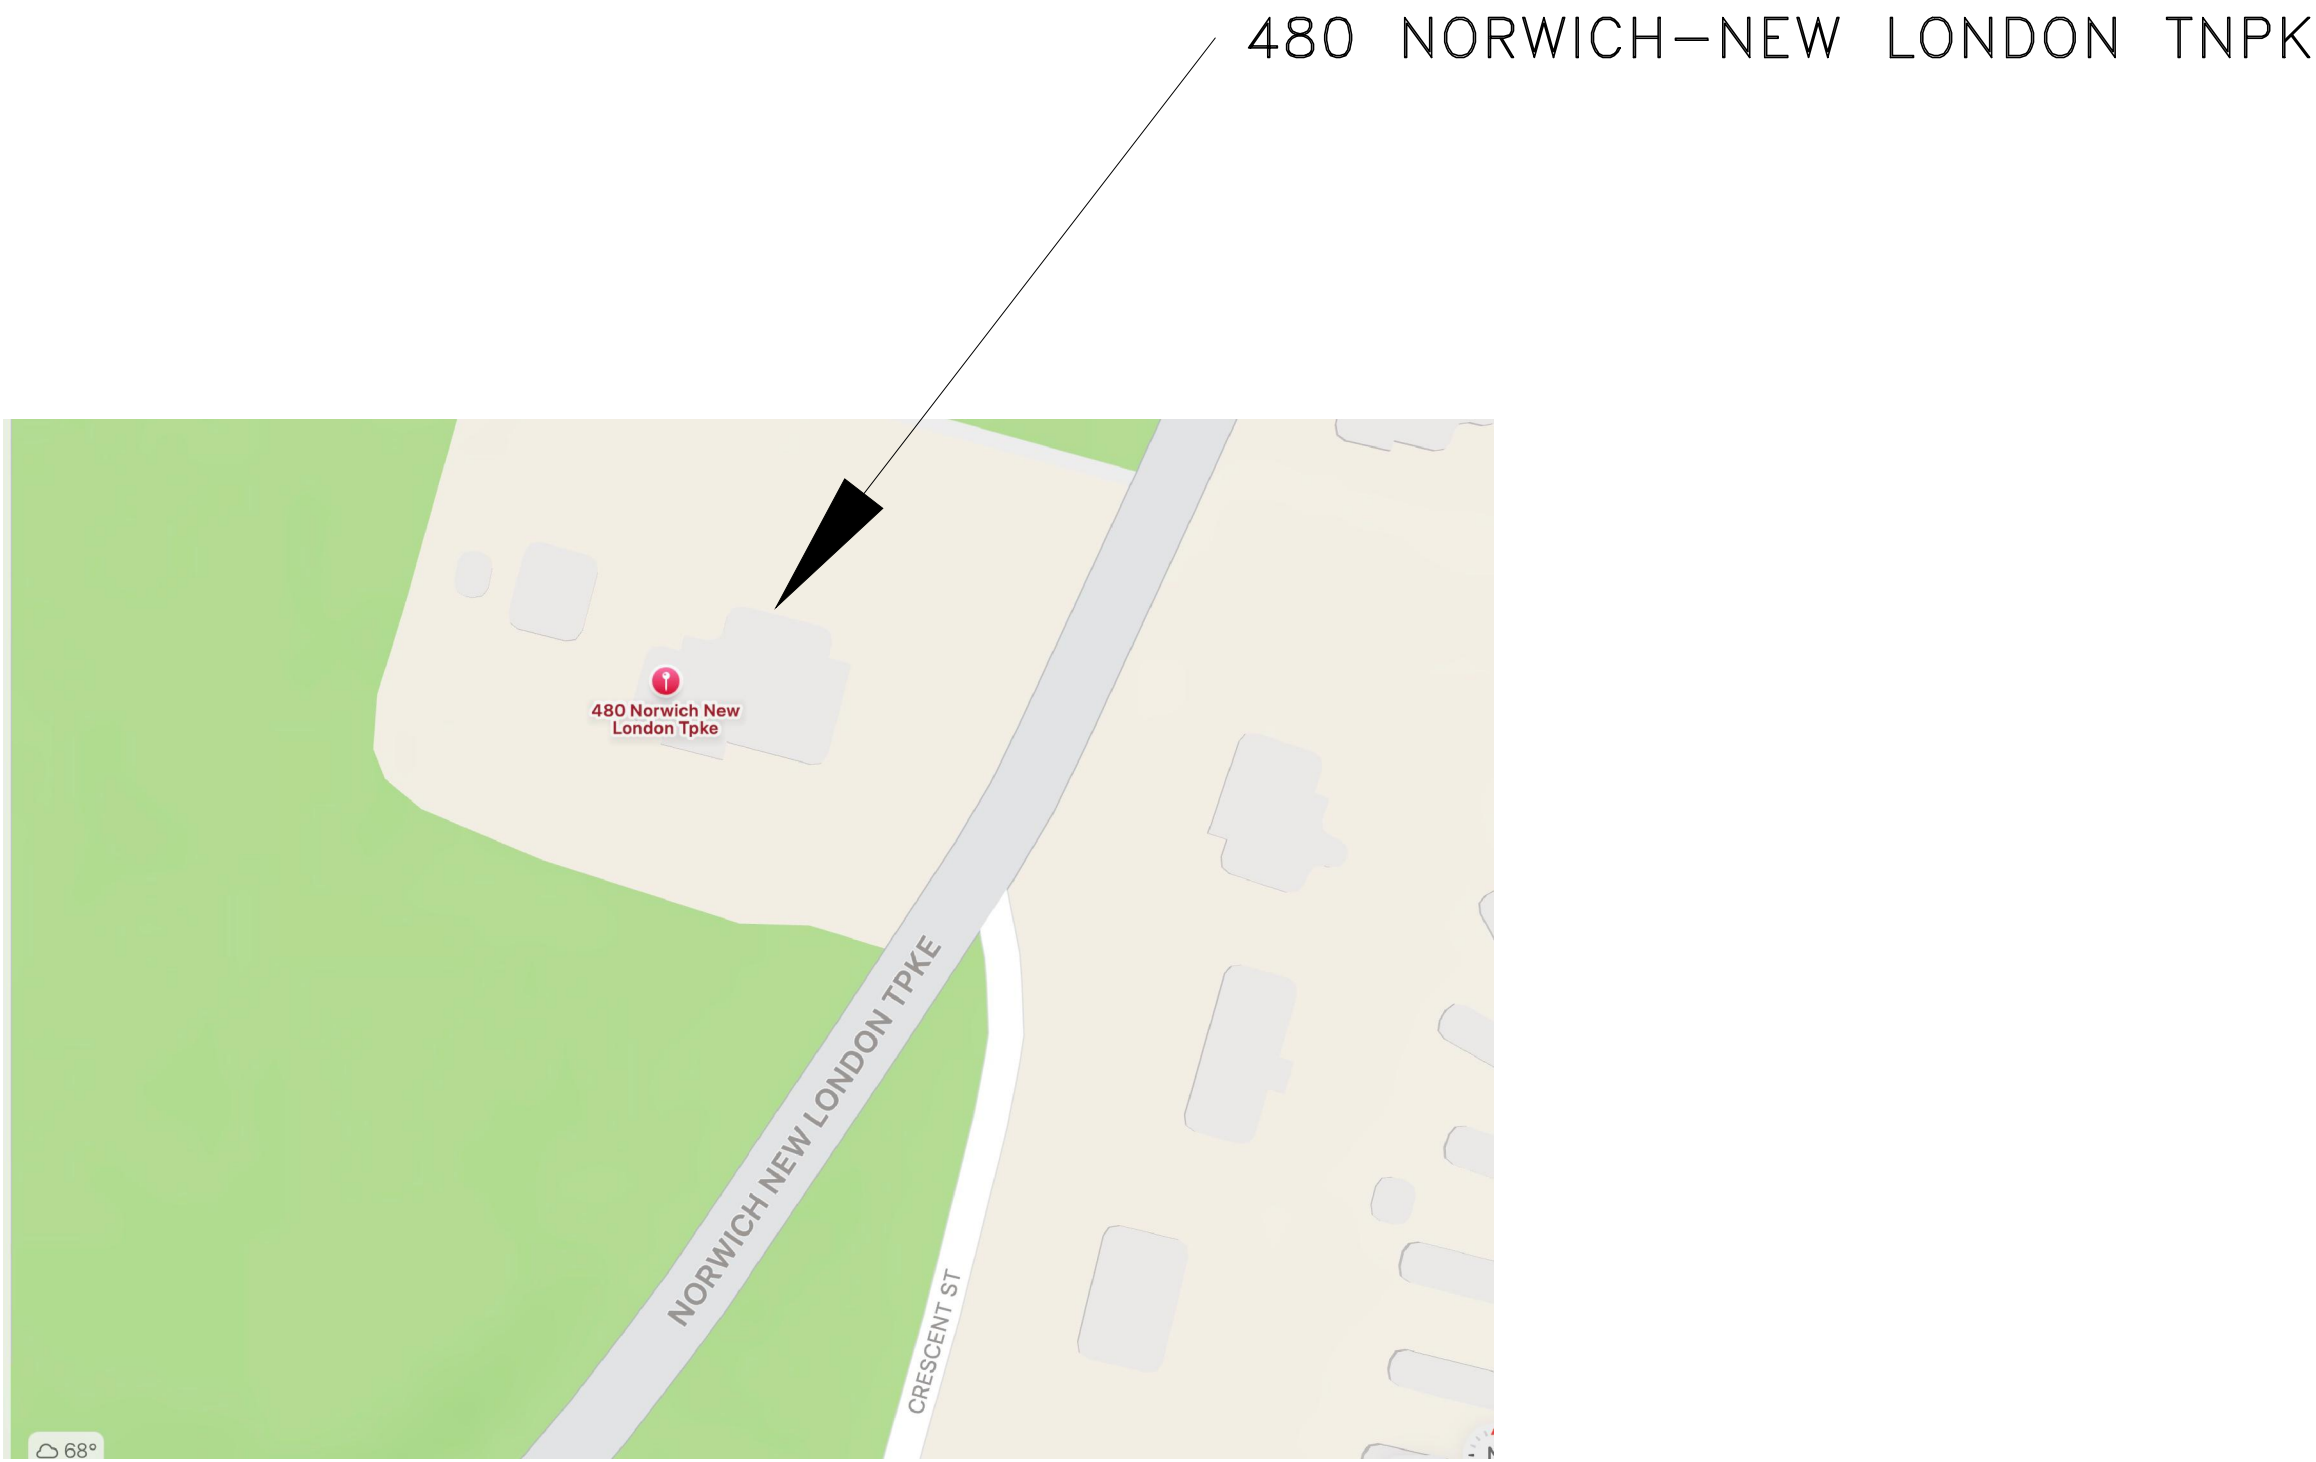

1 CODE REVIEW
A1.0 SCALE: N.T.S.

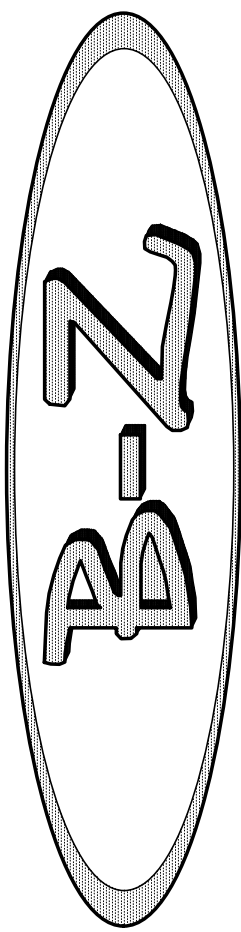

(860) 877-2402
SOUTHINGTON, CT

MIXED-USE BUILDING
RENOVATION PLANS
480 NORWICH-NEW LONDON TNPk
MONTVILLE, CONNECTICUT

PROJECT

REVISIONS

DATE AUGUST 28, 2024

DRAWN DCZ

SCALE AS NOTED


FILE SUD1.DWG

SHEET TITLE

COVER
PAGE

SHEET NO.

A1.0

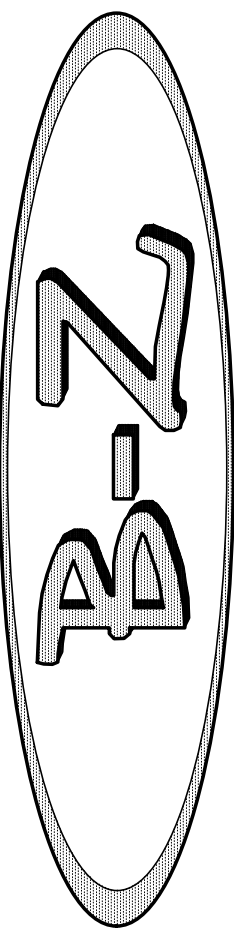

(860) 877-2402
SOUTHINGTON, CT

PROPOSED ADDITION
480 NORWICH-NEW LONDON TNPk
MONTVILLE, CONNECTICUT

PROJECT

REVISIONS


DATE SEPTEMBER 28, 2024
DRAWN DCZ
SCALE AS NOTED
FILE SUD1.DWG

SHEET TITLE

BUILDING
ELEVATIONS


SHEET NO.

A1.1

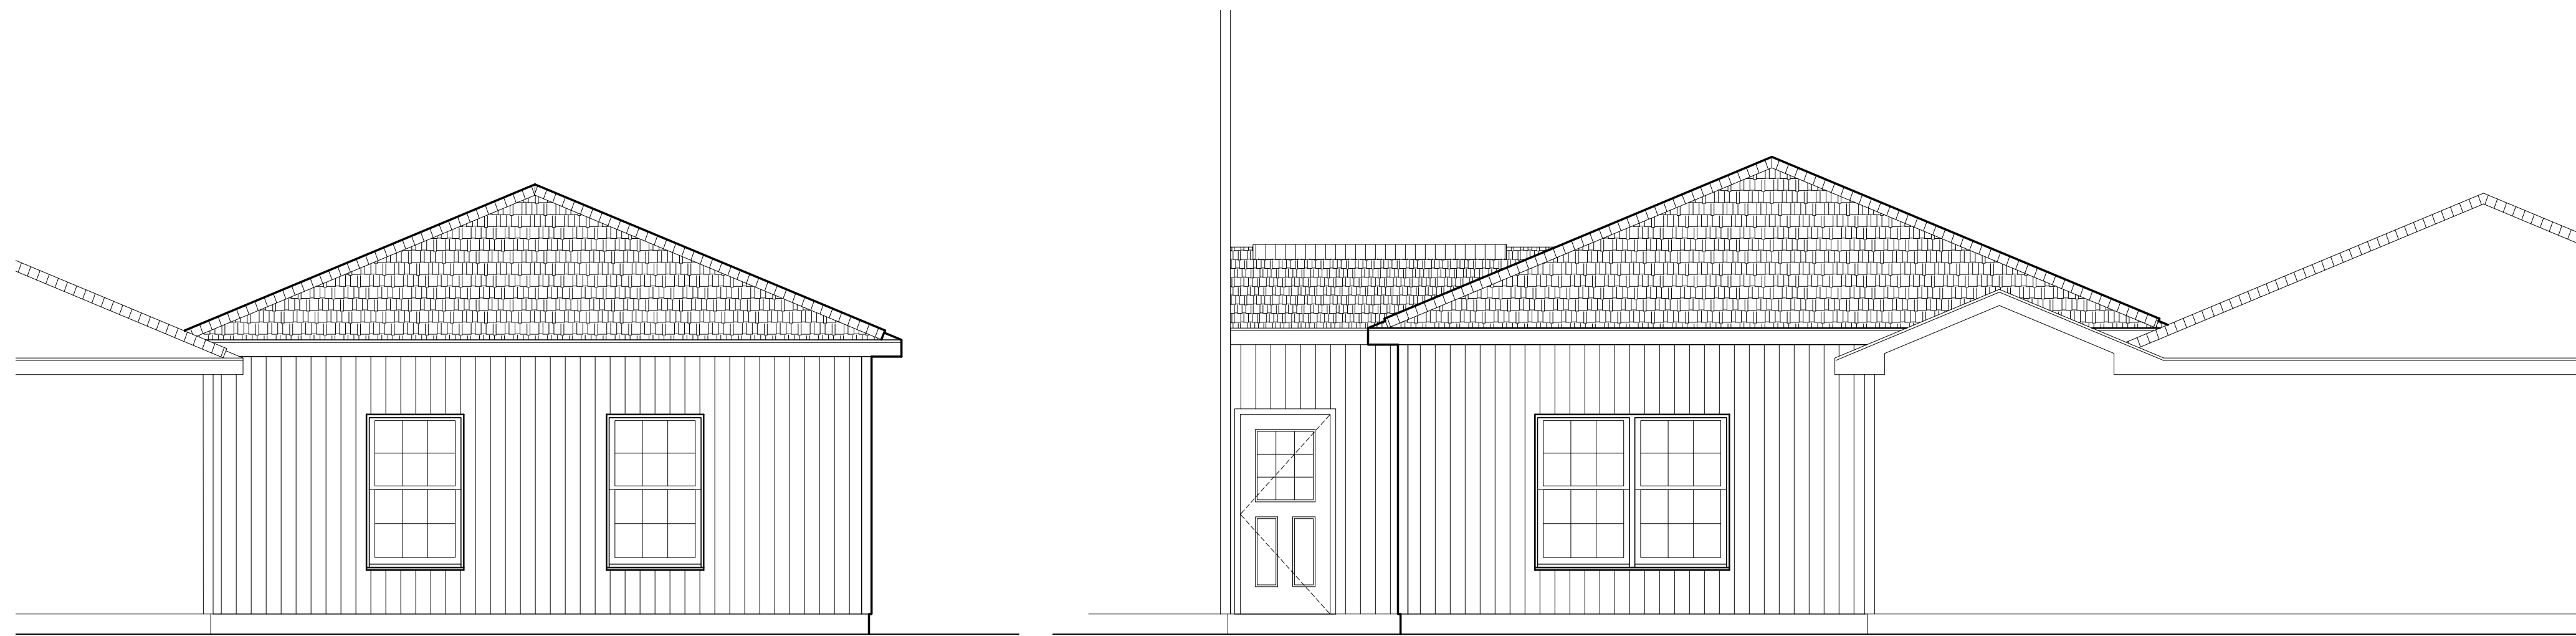


4 WEST ELEVATION
A2.4 SCALE: 1/4"=1'-0"

3 NORTH ELEVATION
A2.4 SCALE: 1/4"=1'-0"

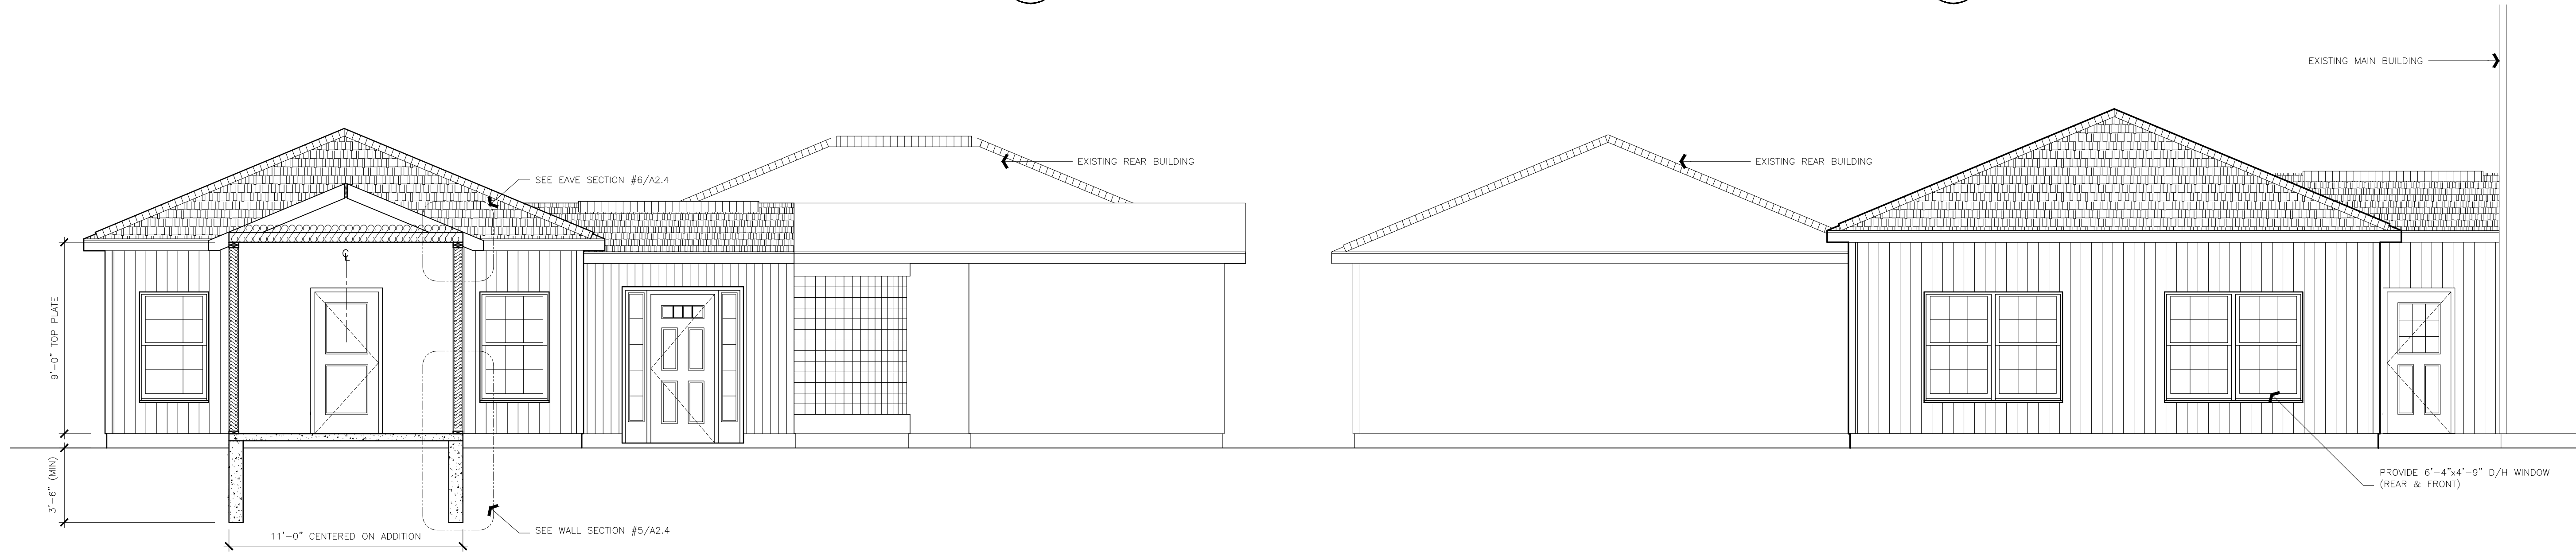


2 EAST ELEVATION
A2.4 SCALE: 1/4"=1'-0"


1 SOUTH ELEVATION
A2.4 SCALE: 1/4"=1'-0"

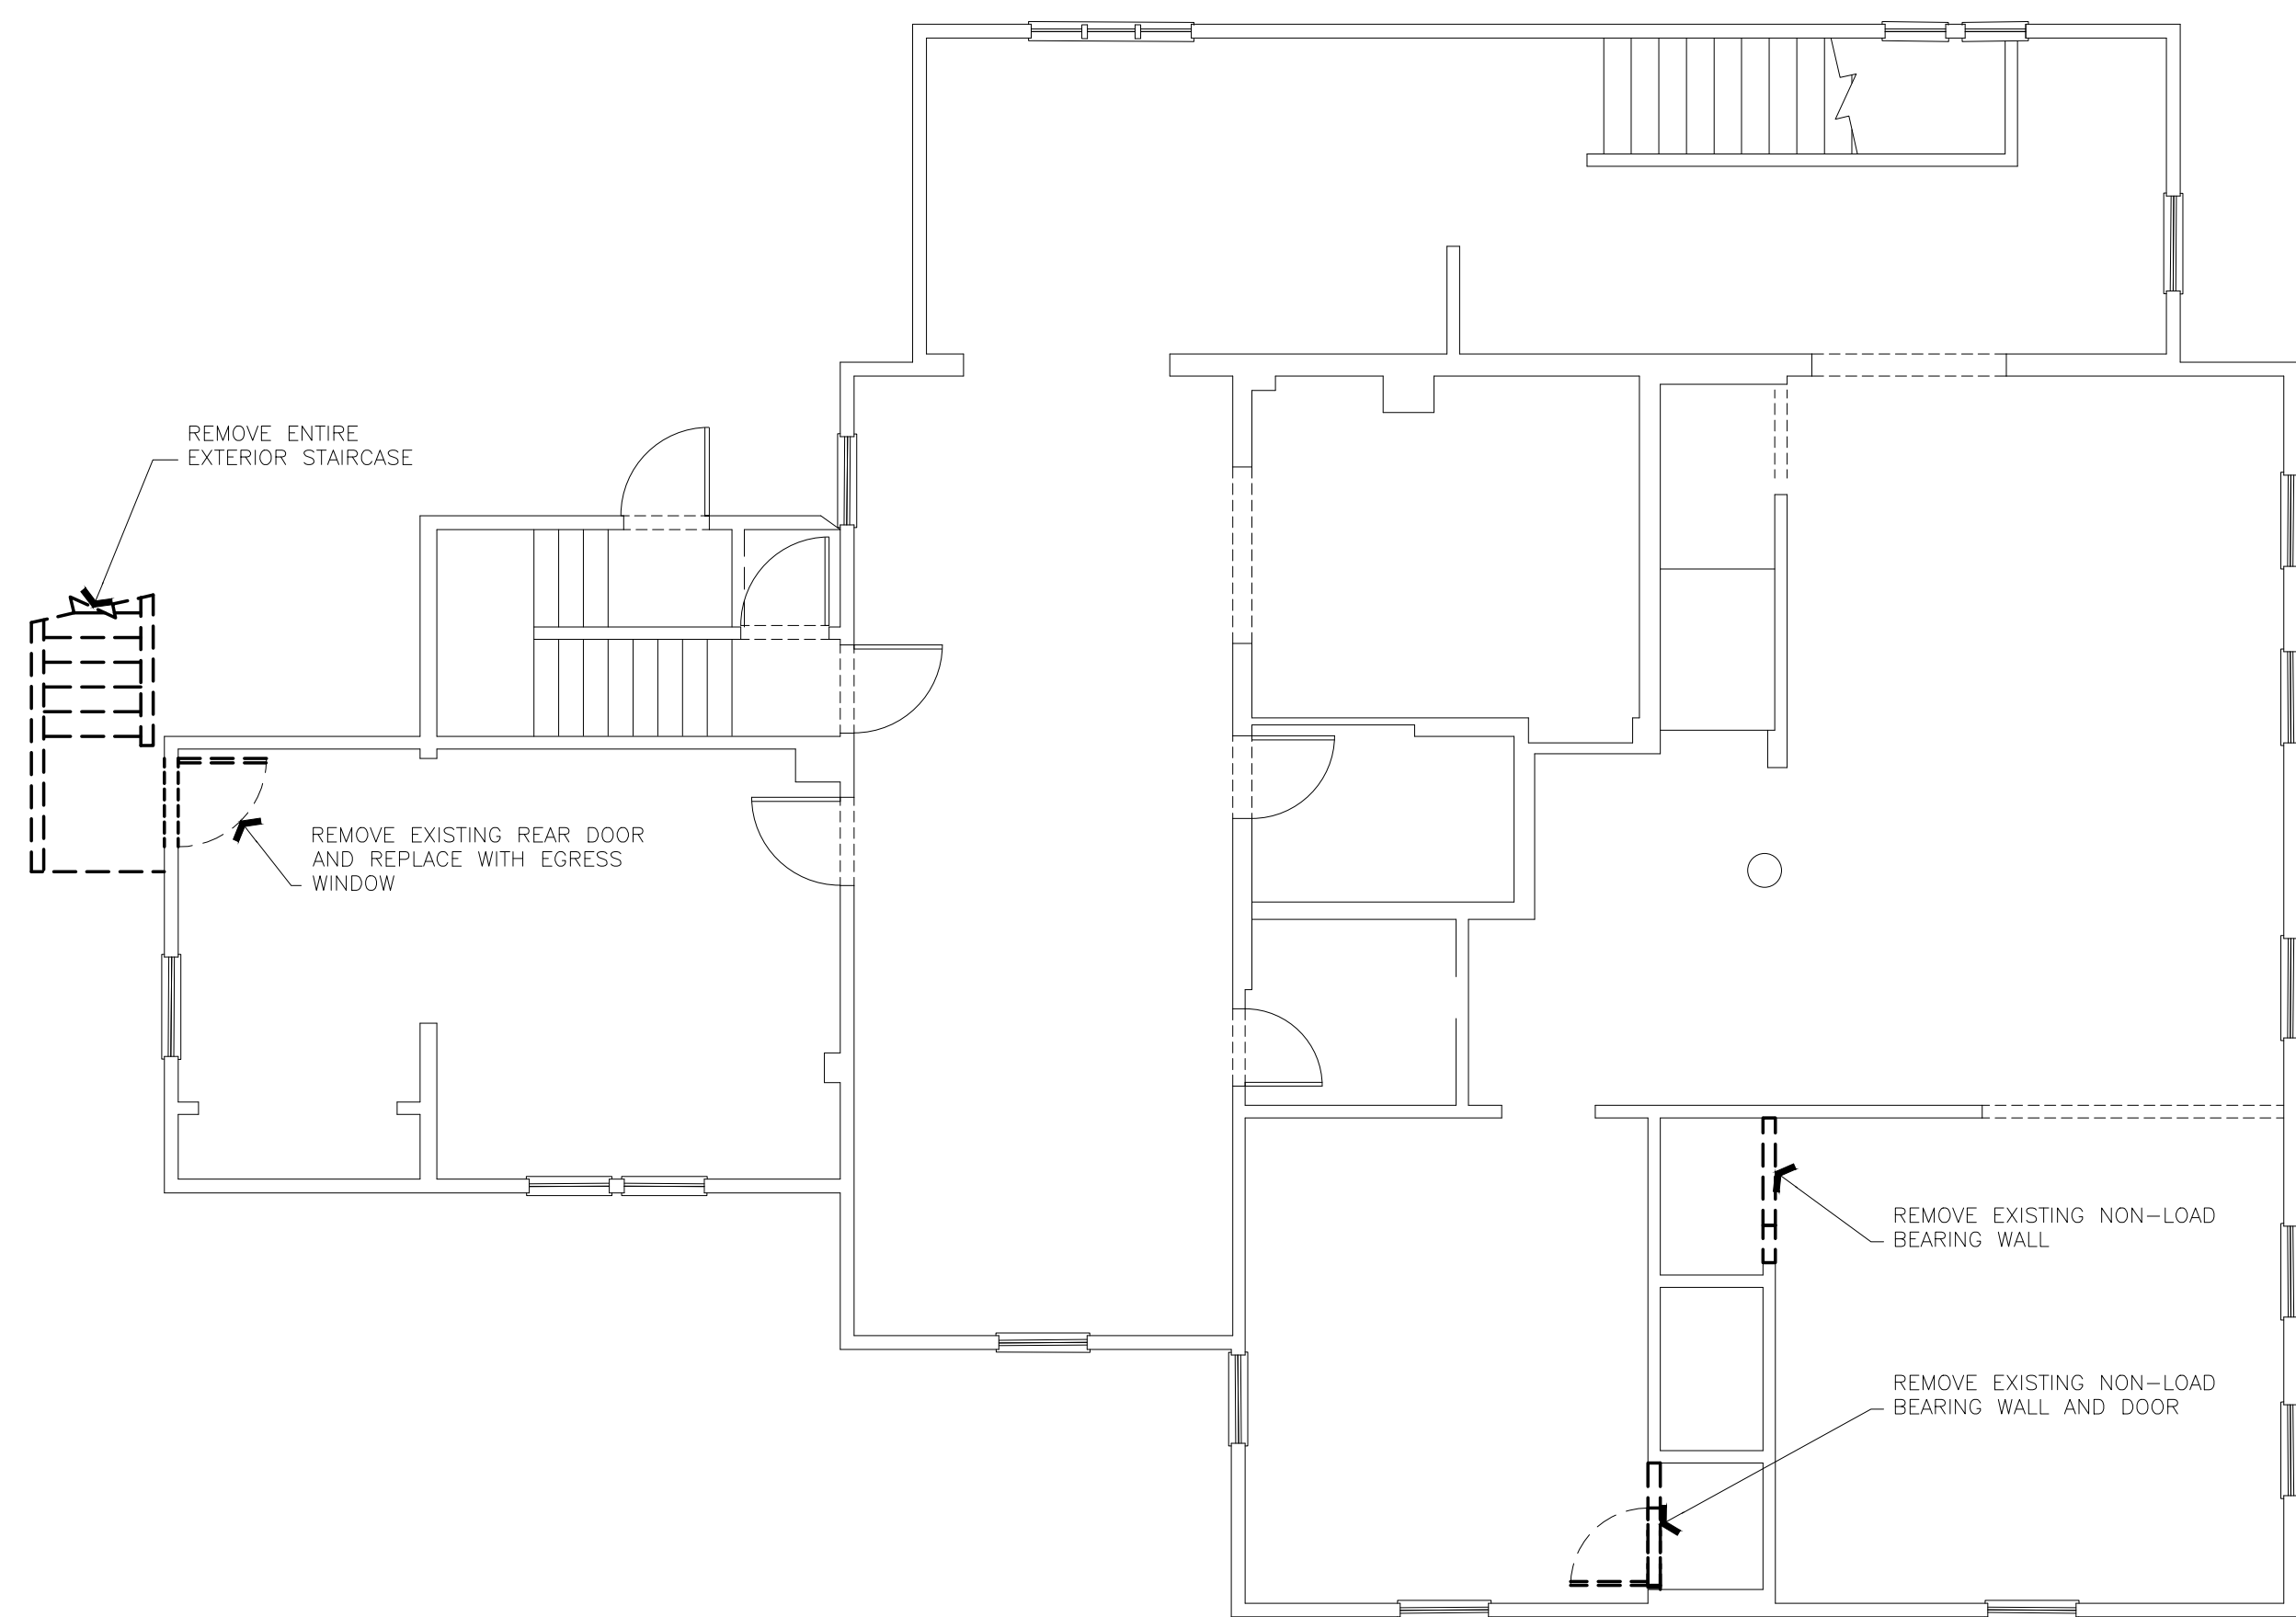

1 UPPER FLOOR ALTERATION PLAN
A1.2 SCALE: 3/16"=1'-0"

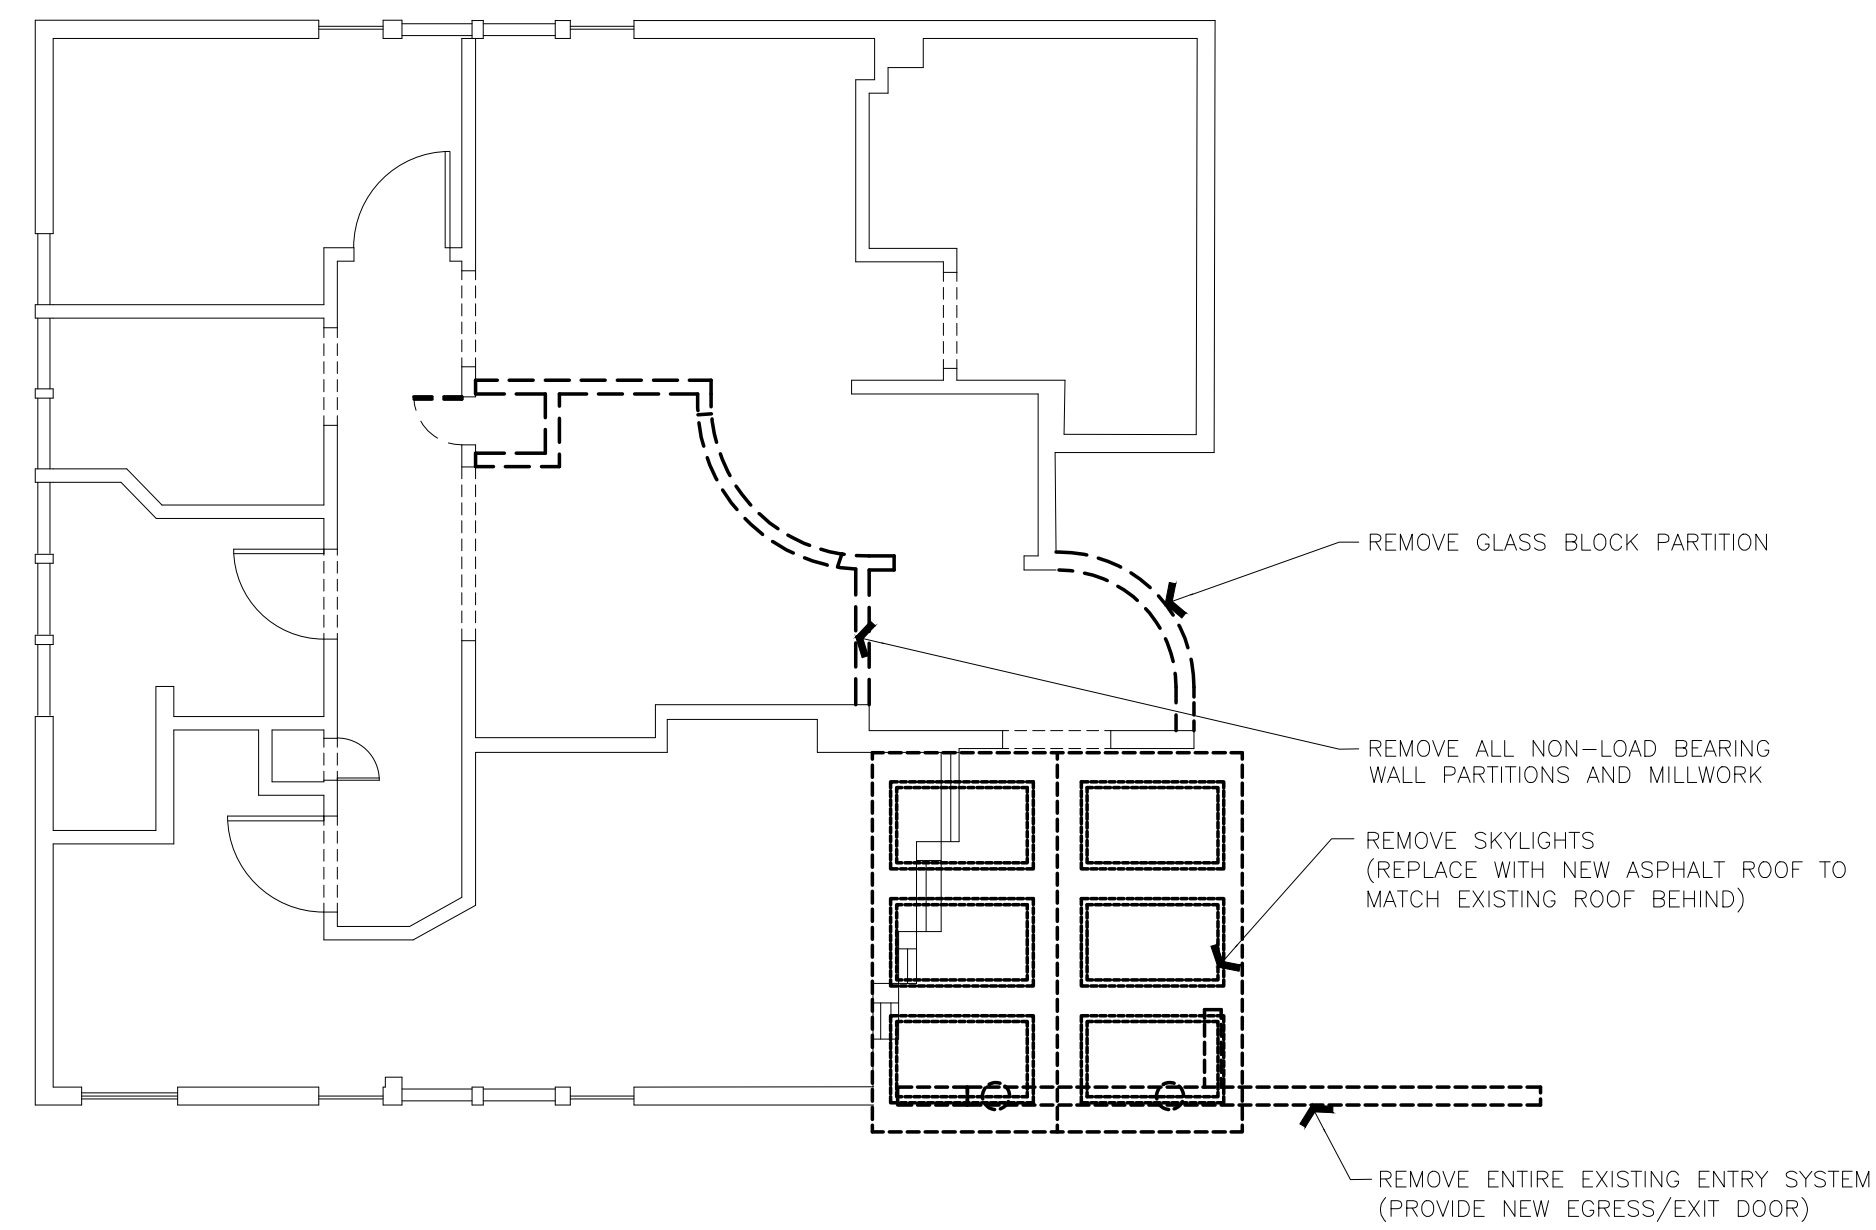

2 MAIN FLOOR ALTERATION PLAN
A1.2 SCALE: 3/16"=1'-0"

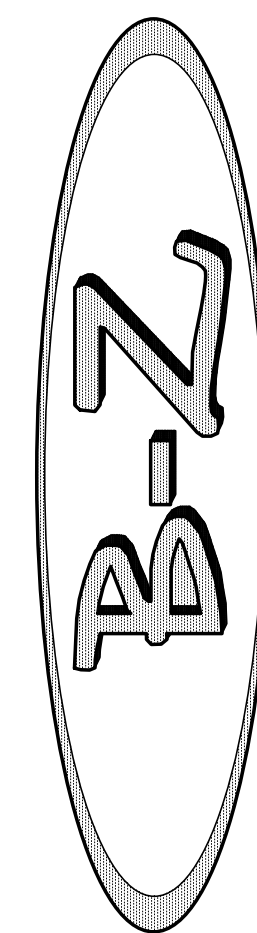

(860) 877-2402
SOUTHINGTON, CT

MIXED-USE BUILDING
RENOVATION PLANS
480 NORWICH-NEW LONDON TNPK
MONTVILLE, CONNECTICUT

PROJECT

REVISIONS

DATE SEPTEMBER 28, 2024

DRAWN DCZ

SCALE AS NOTED

FILE SUD1.DWG

SHEET TITLE

ALTERATION
FLOOR PLANS

SHEET NO.

A2.0



DOOR SCHEDULE			
MARK	DESCRIPTION	SIZE	REMARK
A1	2-PANEL MASONITE	3'-0" x 6'-8"	SECURITY, 90 MIN LABEL, WITH CLOSER
A2	2-PANEL MASONITE	3'-0" x 6'-8"	PASSAGE
A3	2-PANEL MASONITE	3'-0" x 6'-8"	PRIVACY, BATH W/CLOSER
A4	ENTRY DOOR	3'-0" x 6'-8"	SECURITY, HALF-GLAZED
A5	UTILITY DOOR	3'-6" x 6'-8"	PASSAGE, HALF-GLAZED, 180°
A6	2-PANEL MASONITE, BI-FOLD	3'-0" x 6'-8"	PASSAGE
A7	ENTRY DOOR	3'-0" x 6'-8"	SECURITY, HALF-GLAZED, 2-12" SIDELITES

PLUMBING FIXTURE SCHEDULE		
MARK	DESCRIPTION	MFG #
P1	WATER CLOSET-ECO DRAKE ELONGATED 17"H ELONGATED SEAT DRAKE G-MAX TANK	TOTO #C744-EL CHURCH #585EC TOTO #5T743S
P2	LAVATORY "HAYES" 20x18 FAUCET HANGER	GERBER #12-384 DELTA #520-MPU #32121
P3	FIAT SERVICE SINK 24x24	FL-1
P4	S/S KITCHEN SINK FAUCET	OWNER OWNER

ELECTRICAL LIGHTING	
	6'-0" LED TRACK FIXTURE
	8'-0" LED STRIP FIXTURE
	2X2 OR 2X4 SURFACE MOUNTED FIXTURE
	PENDANT LIGHT FIXTURE WITH DIMMABLE LED BULB
	6"x6" SURFACE MOUNT FIRE RATED CAN FIXTURE
	6"x6" RECESSED CAN FIXTURE
	EXTERIOR LIGHTING FIXTURE (PROVIDED BY OWNER)
	CHANDELIER (PROVIDED BY OWNER)
	EXTERIOR DOOR EMERGENCY LIGHT FIXTURE
	EMERGENCY LIGHT FIXTURE
	EXIT LIGHT FIXTURE W/EMERGENCY LIGHT
	H/C EXIT LIGHT FIXTURE W/EMERGENCY LIGHT (SEE BELOW)
	EXIT LIGHT FIXTURE
	DATA CABLE PROVIDED BY TENANT
	CALL FOR AID


ELECTRICAL POWER	
	WALL MOUNTED DUPLEX OUTLET HIGH T.V.
	WALL MOUNTED DUPLEX OUTLET HIGH CAMERA
	WALL MOUNTED DUPLEX OUTLET (18" A.F.F. UNLESS NOTED OTHERWISE, USE G.F.I. IN ALL BATHROOMS AND OTHER WET CONDITION LOCATIONS)
	WALL MOUNTED QUAD OUTLET (18" A.F.F. UNLESS NOTED OTHERWISE, USE G.F.I. IN ALL BATHROOMS AND OTHER WET CONDITION LOCATIONS)
	WALL MOUNTED DUPLEX OUTLET WITH USB
	FLOOR MOUNTED DUPLEX OUTLET
	CEILING DROP DUPLEX OUTLET
	WALL MOUNTED SINGLE POLE SWITCH
	WALL MOUNTED 2-POLE SWITCH
	WALL MOUNTED DIMMER/SWITCH
	WALL MOUNTED MOTION/SWITCH

ELECTRICAL FIRE	
	HORN STROBE
	FIRE PULL SWITCH
	SMOKE DETECTOR

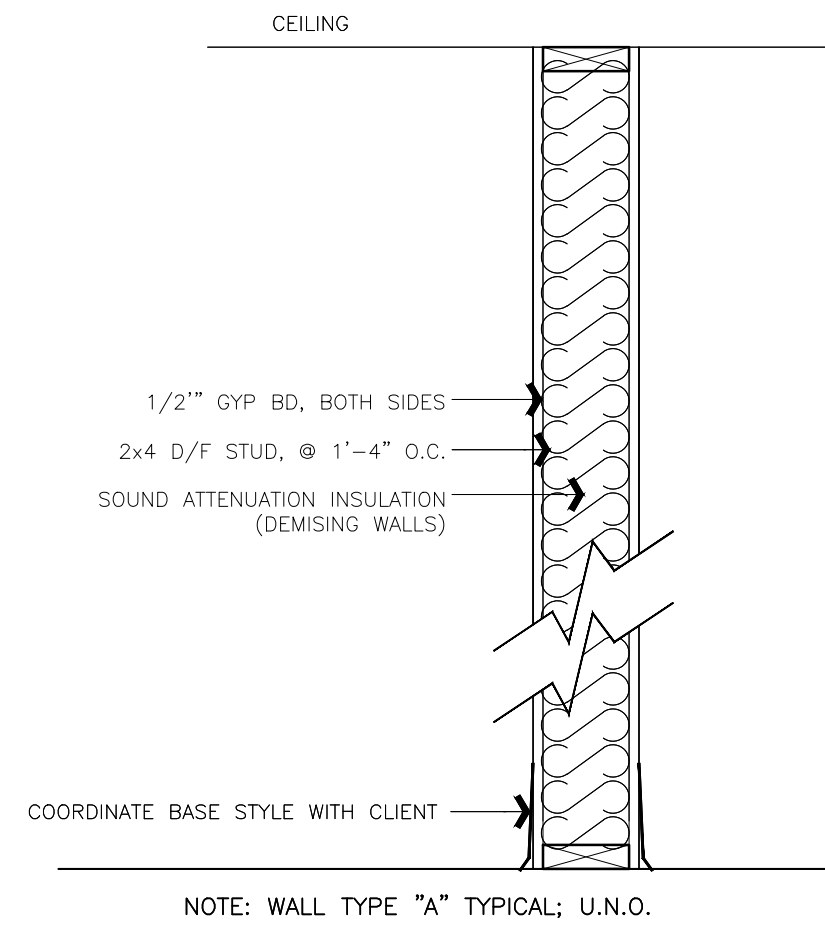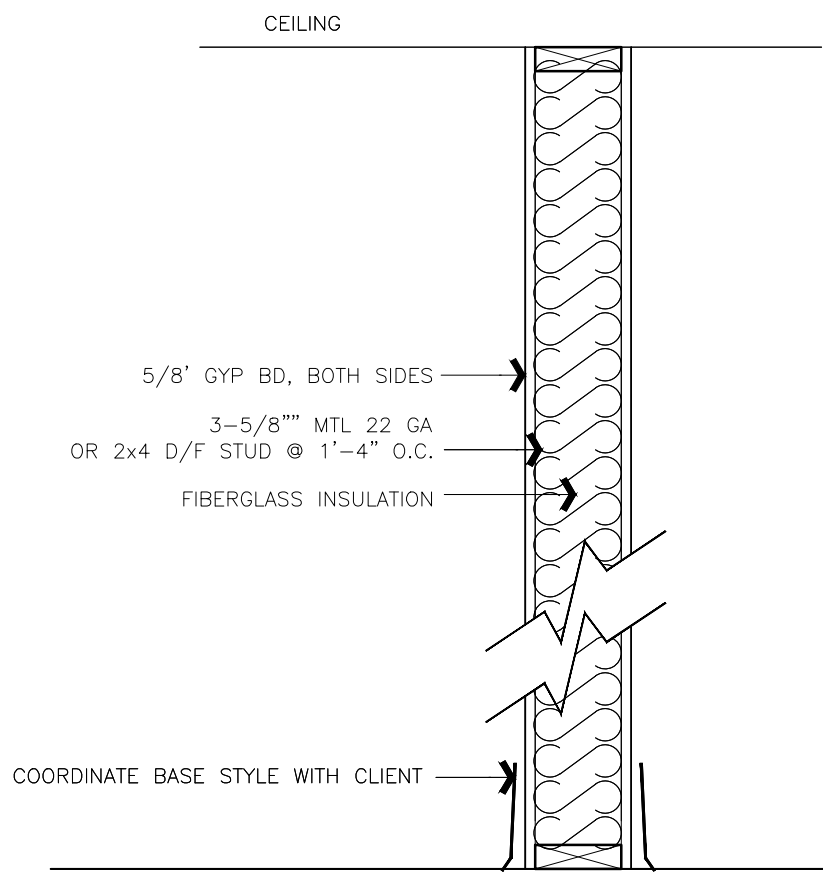


3 WALL TYPE "B"
A2.1 SCALE: 1"=1'-0"

2 WALL TYPE "A"
A2.1 SCALE: 1"=1'-0"

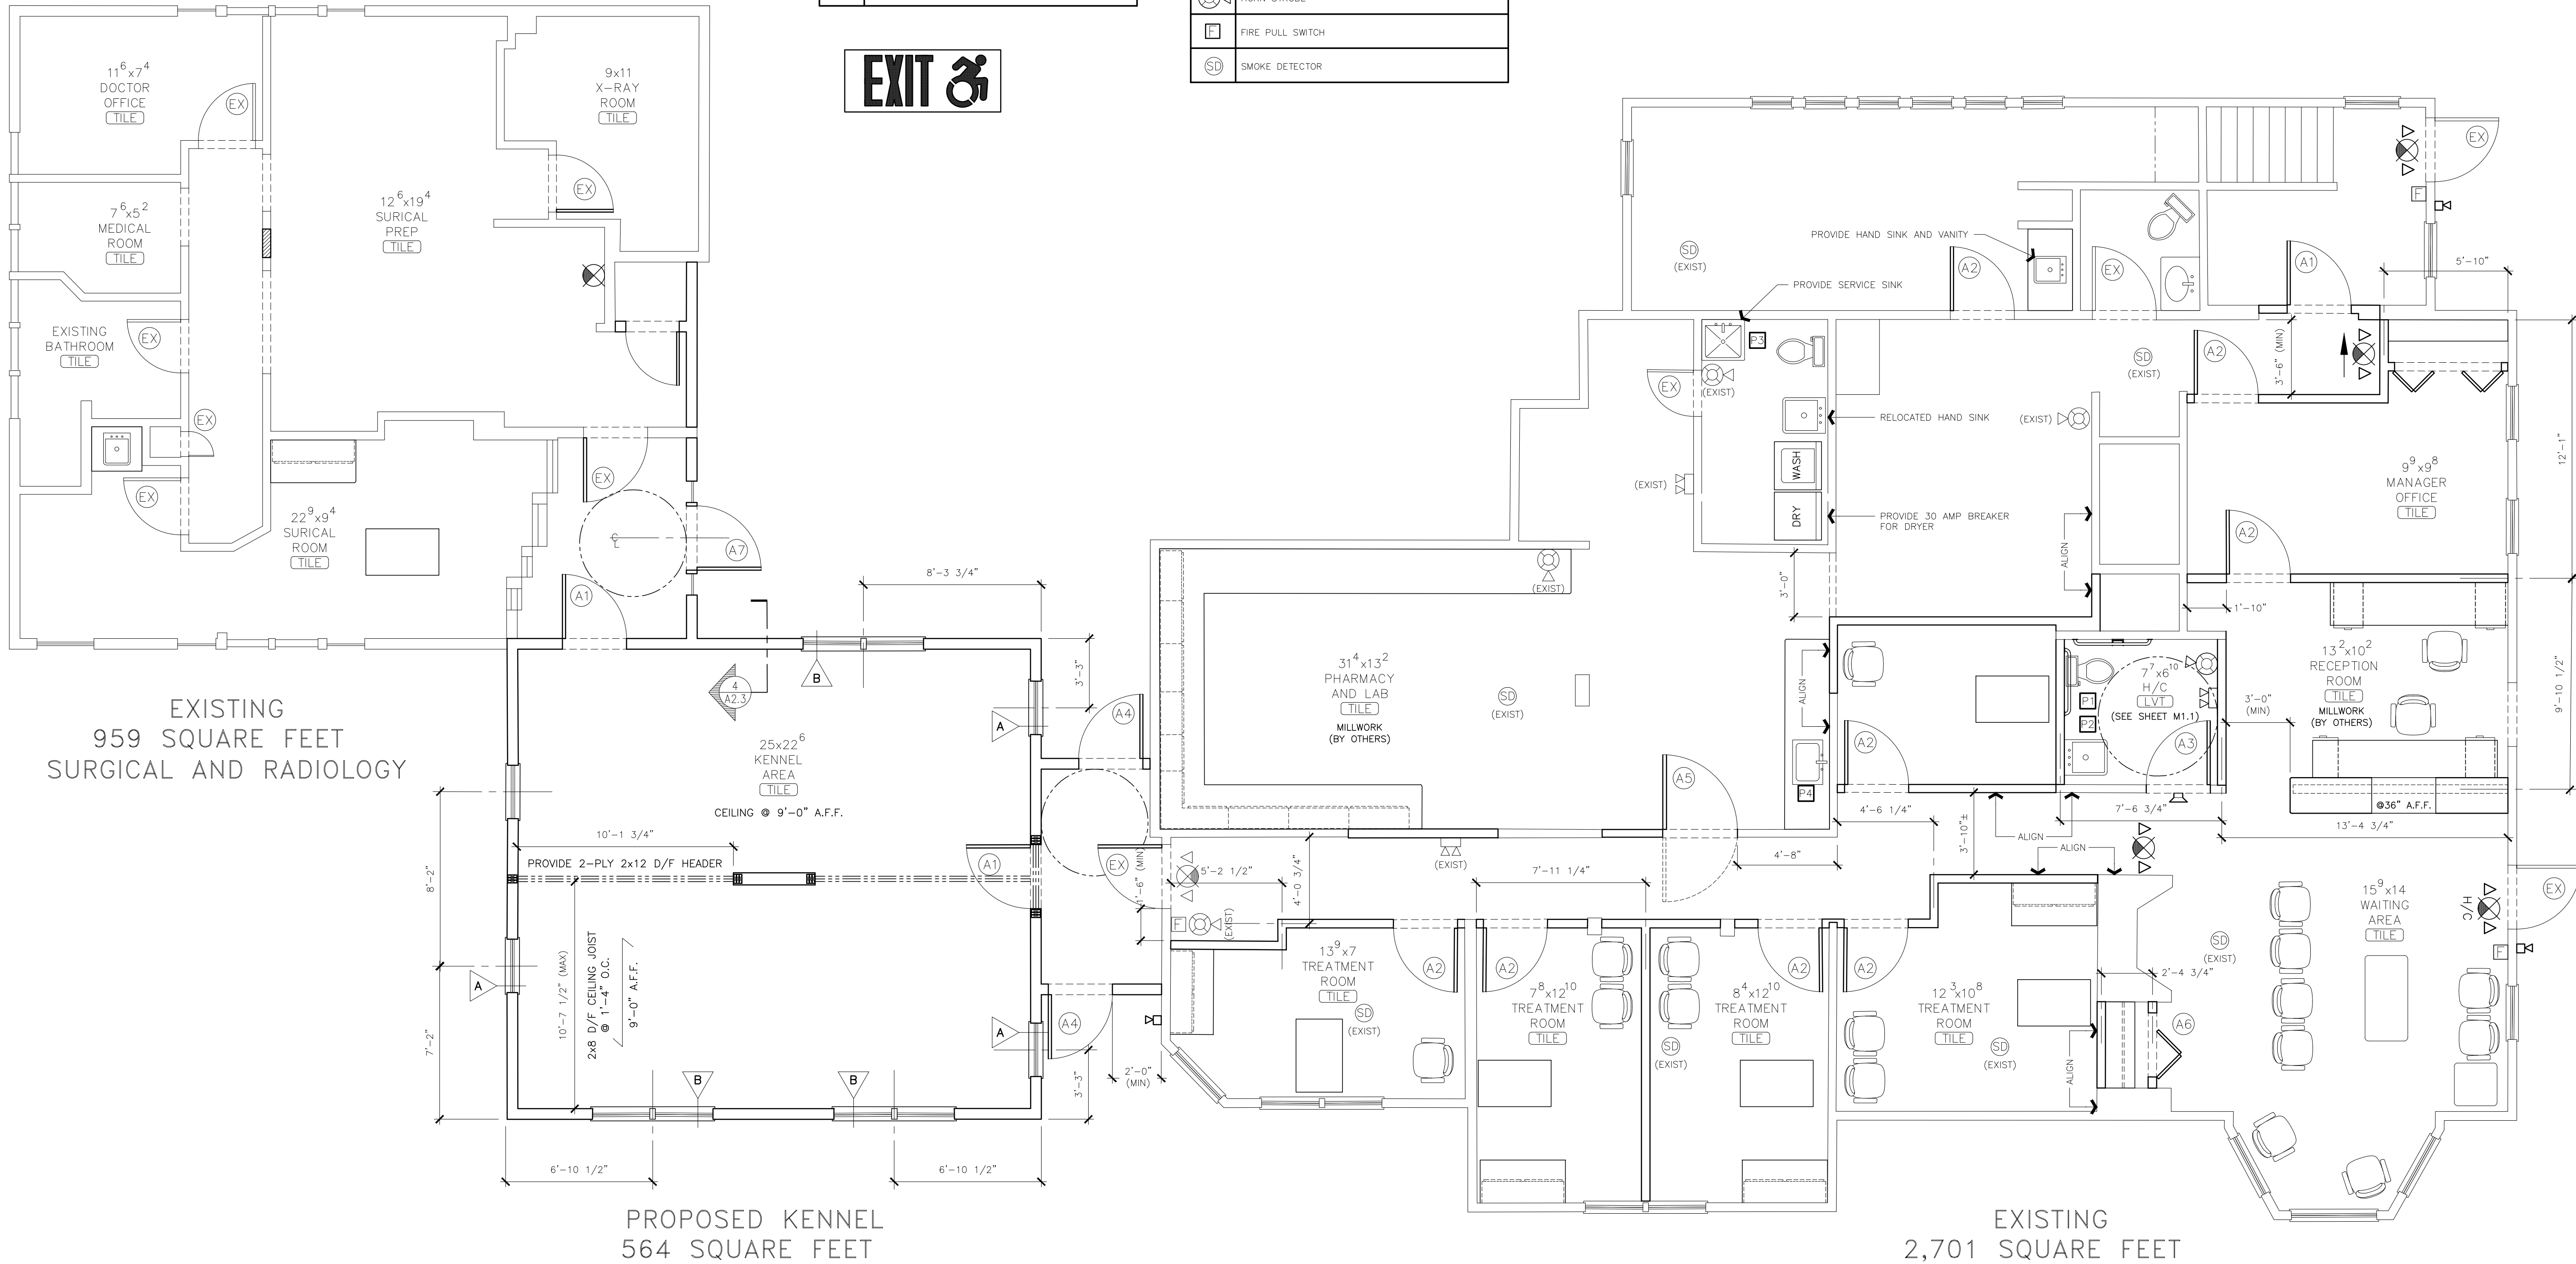

1 MAIN FLOOR PLAN
A2.1 SCALE: 1/4"=1'-0"

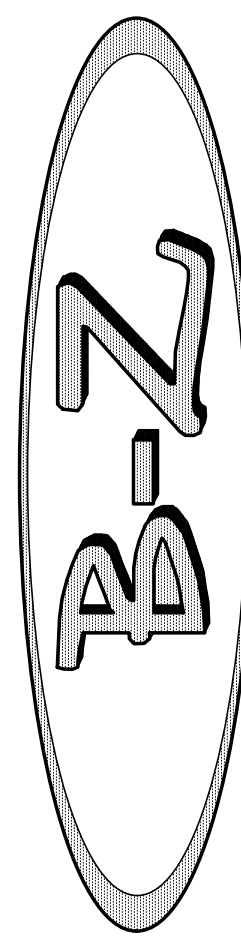

(860) 877-2402
SOUTHINGTON, CT

MIXED-USE BUILDING
RENOVATION PLANS
480 NORWICH-NEW LONDON TNPk
MONTVILLE, CONNECTICUT

PROJECT

REVISIONS

DATE SEPTEMBER 28, 2024

DRAWN DCZ

SCALE AS NOTED

FILE SUD1.DWG

SHEET TITLE

PROPOSED
FLOOR PLANS

SHEET NO.

A2.1



MONTVILLE, CONNECTICUT

CEILING

5/8" GYP BD, BOTH SIDES

3-5/8" MTL 22 GA
OR 2x4 D/F STUD @ 1'-4" O.C.

FIBERGLASS INSULATION

COORDINATE BASE STYLE WITH CLIENT

CEILING

1/2" GYP BD, BOTH SIDES

2x4 D/F STUD, @ 1'-4" O.C.

SOUND ATTENUATION INSULATION
(DEMISING WALLS)

COORDINATE BASE STYLE WITH CLIENT

NOTE: WALL TYPE "A" TYPICAL; U.N.O.



2 WALL TYPE "A"
A2.2 SCALE: 1"=1'-0"

1 UPPER FLOOR PLAN
A2.2 SCALE: 1/4"=1'-0"

A2.2

